


CABINET'S PAINT OR STAIN
 CABINET DETAIL IS
 FOR ILLUSTRATION ONLY
 ACTUAL LAYOUT TO BE
 PROVIDED BY CABINET
 INSTALLATION COMPANY

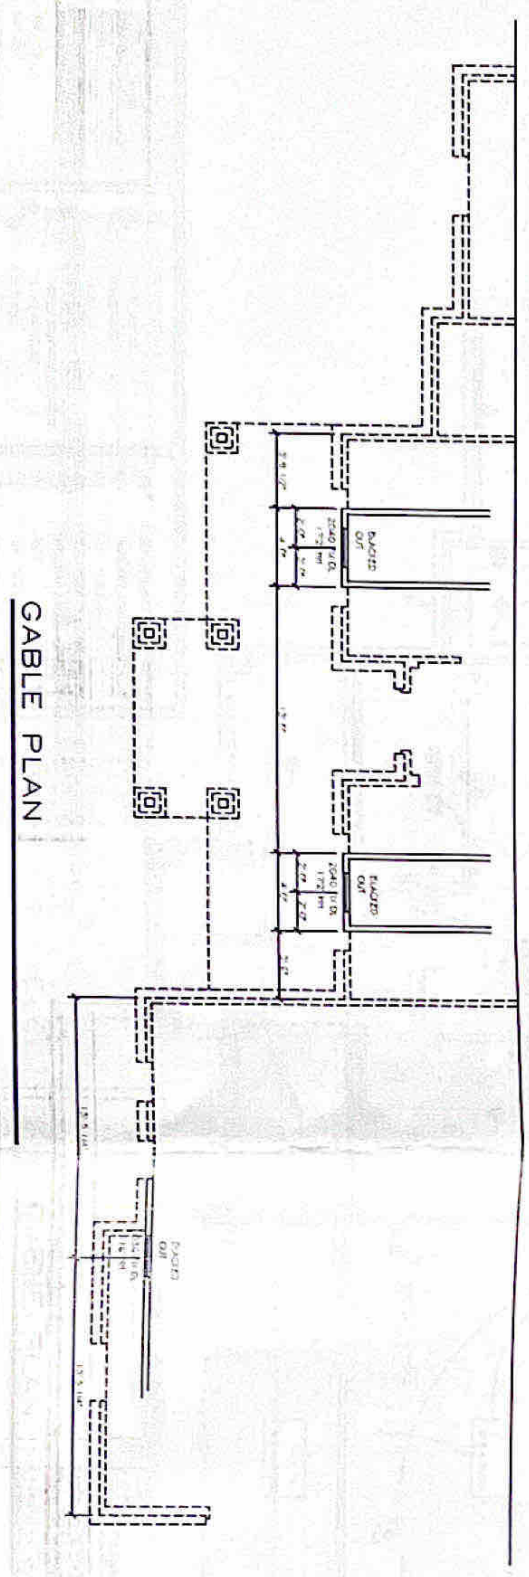

DOOR SCHEDULE	
NO.	DESCRIPTION
1	6'0" x 8'0" - 1/2" - 1/2"
2	6'0" x 8'0" - 1/2" - 1/2"
3	6'0" x 8'0" - 1/2" - 1/2"
100	6'0" x 8'0" - 1/2" - 1/2"

Crown Ridge Builders
 Houston, TEXAS
 281-682-5593
 email: nichelle@crowridgebuilders.com


Homestead Designs
 Plano, TEXAS
 214-215-1013
 e-mail: homestead_designs@verizon.net

ALL COPY RIGHTS ARE THE SOLE PROPERTY OF HOMESTEAD DESIGNS

PROJECT ADDRESS: 205 HODGAN
 REVISION DATE: 06-02-2022 BLP
 PLAN NUMBER: 3046
 DESIGNED AND DRAWN BY: HOMESTEAD DESIGN
 CHECKED BY: S.J. HILLIS
 DATE: 21-4-21-1013


PAGE # 2

ELECTRICAL LEGEND	
⊕	WIRE BOND
⊖	SWITCH
⊕ ⊖	THREE-WAY SWITCH
⊕ ⊖ ⊕	FOUR-WAY SWITCH
⊕ ⊖ ⊕ ⊖	RECESSIT
⊕ ⊖ ⊕ ⊖ ⊕	COUNTERTOP OUTLET
⊕ ⊖ ⊕ ⊖ ⊕ ⊖	SPAT WARD OUTLET
⊕ ⊖ ⊕ ⊖ ⊕ ⊖ ⊕	QUADRA-BOX
⊕ ⊖ ⊕ ⊖ ⊕ ⊖ ⊕ ⊖	COAXIAL OUTLET
⊕ ⊖ ⊕ ⊖ ⊕ ⊖ ⊕ ⊖ ⊕	FLOOR OUTLET
⊕ ⊖ ⊕ ⊖ ⊕ ⊖ ⊕ ⊖ ⊕ ⊖	PHONE OUTLET
⊕ ⊖ ⊕ ⊖ ⊕ ⊖ ⊕ ⊖ ⊕ ⊖ ⊕	TV OUTLET
⊕ ⊖ ⊕ ⊖ ⊕ ⊖ ⊕ ⊖ ⊕ ⊖ ⊕ ⊖	Gas OUTLET
⊕ ⊖ ⊕ ⊖ ⊕ ⊖ ⊕ ⊖ ⊕ ⊖ ⊕ ⊖ ⊕	CARBON MONOXIDE DETECTOR
⊕ ⊖ ⊕ ⊖ ⊕ ⊖ ⊕ ⊖ ⊕ ⊖ ⊕ ⊖ ⊕ ⊖	SMOKE DETECTOR
⊕ ⊖ ⊕ ⊖ ⊕ ⊖ ⊕ ⊖ ⊕ ⊖ ⊕ ⊖ ⊕ ⊖ ⊕	AMERICAN
⊕ ⊖ ⊕ ⊖ ⊕ ⊖ ⊕ ⊖ ⊕ ⊖ ⊕ ⊖ ⊕ ⊖ ⊕ ⊖	220 VOLT OUTLET
⊕ ⊖ ⊕ ⊖ ⊕ ⊖ ⊕ ⊖ ⊕ ⊖ ⊕ ⊖ ⊕ ⊖ ⊕ ⊖ ⊕	LANDSCAPING LIGHT
⊕ ⊖ ⊕ ⊖ ⊕ ⊖ ⊕ ⊖ ⊕ ⊖ ⊕ ⊖ ⊕ ⊖ ⊕ ⊖ ⊕ ⊖	RECESSIT COILING LIGHT
⊕ ⊖ ⊕ ⊖ ⊕ ⊖ ⊕ ⊖ ⊕ ⊖ ⊕ ⊖ ⊕ ⊖ ⊕ ⊖ ⊕ ⊖ ⊕	RECESSIT COILING LIGHT
⊕ ⊖ ⊕ ⊖ ⊕ ⊖ ⊕ ⊖ ⊕ ⊖ ⊕ ⊖ ⊕ ⊖ ⊕ ⊖ ⊕ ⊖ ⊕ ⊖	WALL WARD LIGHT
⊕ ⊖ ⊕ ⊖ ⊕ ⊖ ⊕ ⊖ ⊕ ⊖ ⊕ ⊖ ⊕ ⊖ ⊕ ⊖ ⊕ ⊖ ⊕ ⊖ ⊕	WALL WARD FAN
⊕ ⊖ ⊕ ⊖ ⊕ ⊖ ⊕ ⊖ ⊕ ⊖ ⊕ ⊖ ⊕ ⊖ ⊕ ⊖ ⊕ ⊖ ⊕ ⊖ ⊕ ⊖	RECESSIT CEILING LIGHT
⊕ ⊖ ⊕ ⊖ ⊕ ⊖ ⊕ ⊖ ⊕ ⊖ ⊕ ⊖ ⊕ ⊖ ⊕ ⊖ ⊕ ⊖ ⊕ ⊖ ⊕ ⊖ ⊕	VOLT AND LIGHT
⊕ ⊖ ⊕ ⊖ ⊕ ⊖ ⊕ ⊖ ⊕ ⊖ ⊕ ⊖ ⊕ ⊖ ⊕ ⊖ ⊕ ⊖ ⊕ ⊖ ⊕ ⊖ ⊕ ⊕	HEAT AND LIGHT
⊕ ⊖ ⊕ ⊖ ⊕ ⊖ ⊕ ⊖ ⊕ ⊖ ⊕ ⊖ ⊕ ⊖ ⊕ ⊖ ⊕ ⊖ ⊕ ⊖ ⊕ ⊖ ⊕ ⊕ ⊕	HEAT, VOLT AND LIGHT

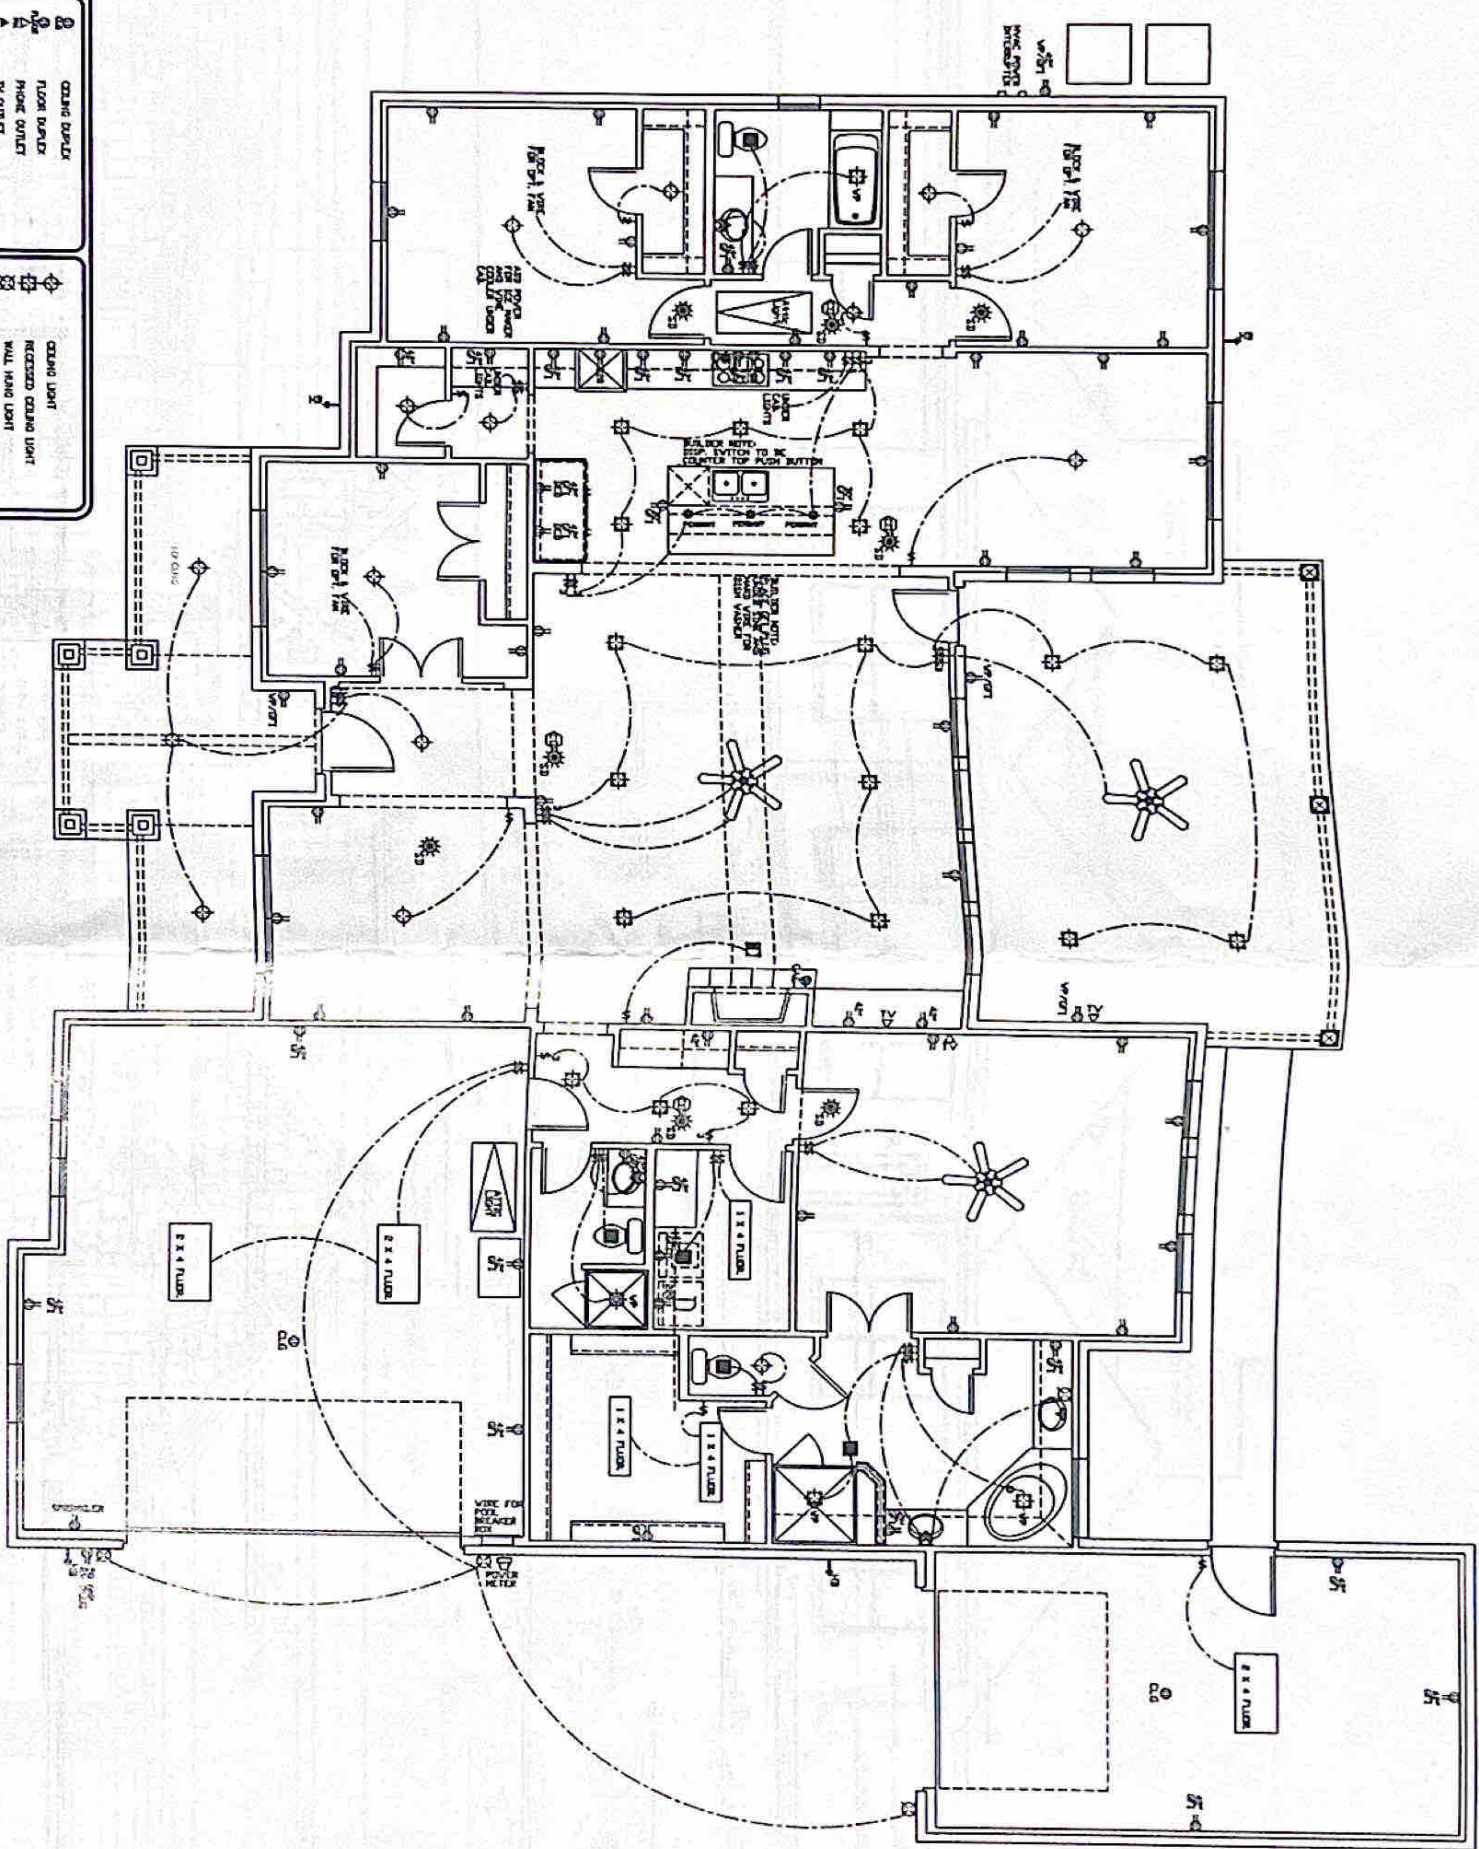


ELECTRICAL PLAN

<p>PROJECT ADDRESS 205 HOGAN</p>	<p>REVISION DATE 06-10-0222 BLP</p>	<p>Crown Ridge Builders Houston, TEXAS 281-682-5593 e-mail: michelle@crowridgebuilders.com</p>	<p>Homestead Designs Plano, TEXAS 214-215-1013 e-mail: homestead.designs@verizon.net</p>	<p>ALL COPY RIGHTS ARE THE SOLE PROPERTY OF HOMESTEAD DESIGNS</p>
<p>DATE: 2-4-015-1013</p>	<p>SCALE: 1/8" = 1'-0"</p>	<p>PROJECT: 205 HOGAN</p>	<p>DESIGNER: MICHELLE</p>	<p>PAGE: 9 3</p>

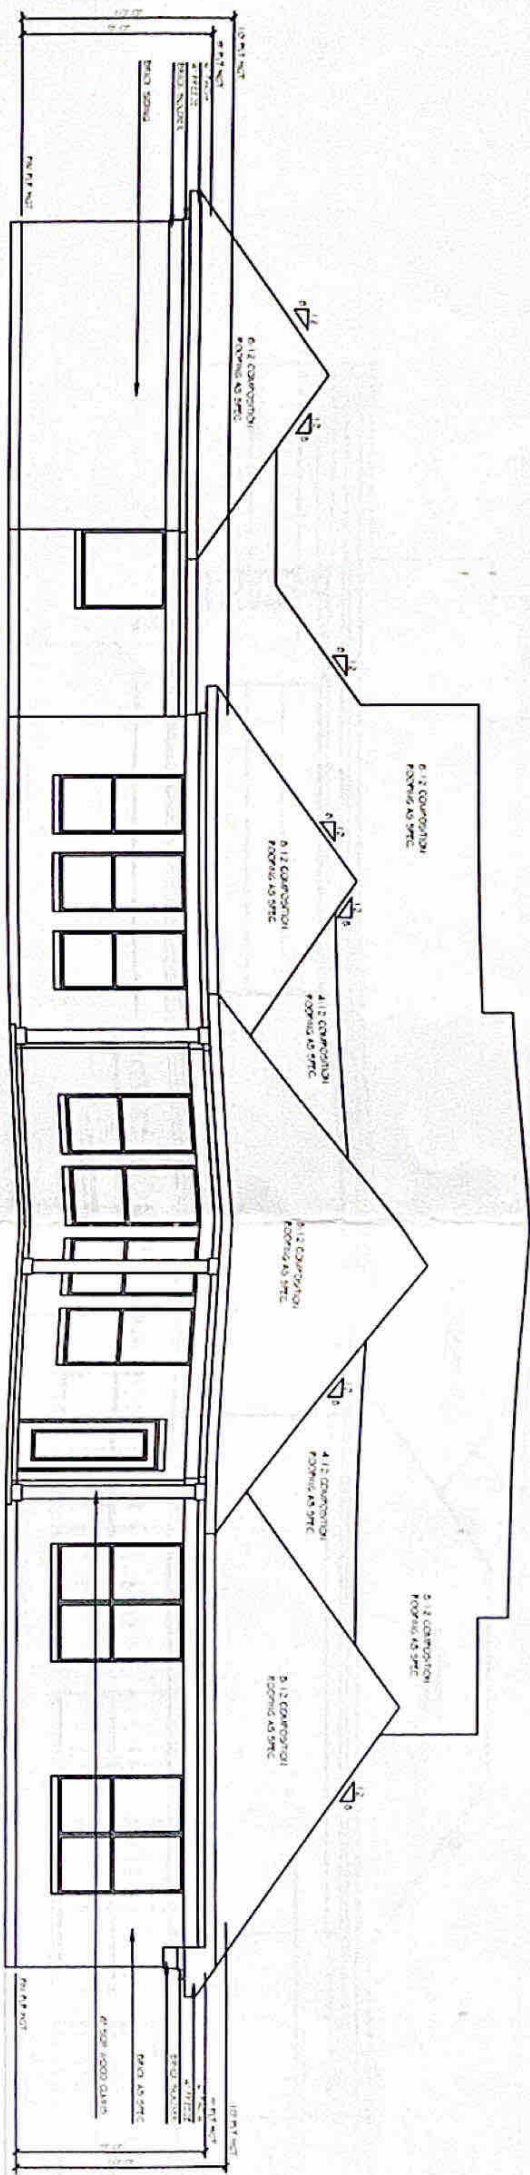

REAR ELEVATION

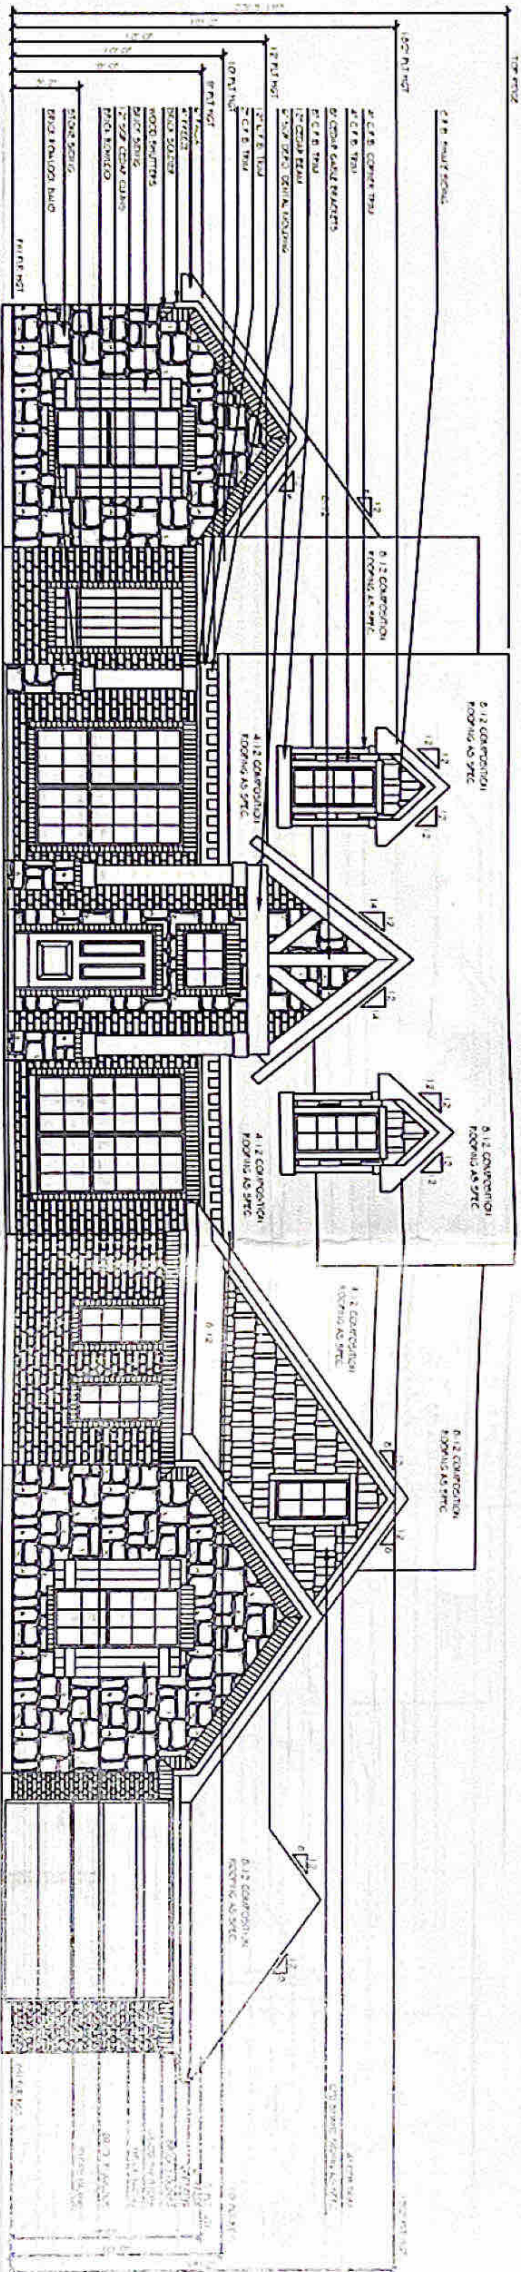

FRONT ELEVATION

ALL COPY RIGHTS ARE THE SOLE PROPERTY OF HOMESTEAD DESIGNS

Homestead Designs

Plano, TEXAS
214-215-1013

e-mail: homestead.designs@verizon.net

Crown Ridge Builders

Houston, TEXAS
281-682-5593


e-mail: mcshelle@crowridgebuilders.com

REVISION DATE
06-09-2022 BLP


PROJECT ADDRESS:
207 HOGAN

PLAN NUMBER
2348

DESIGNED AND DRAWN BY:
HOMESTEAD DESIGNS
B. PHILLIPS
FOUNDER-DESIGNER
214-215-1013

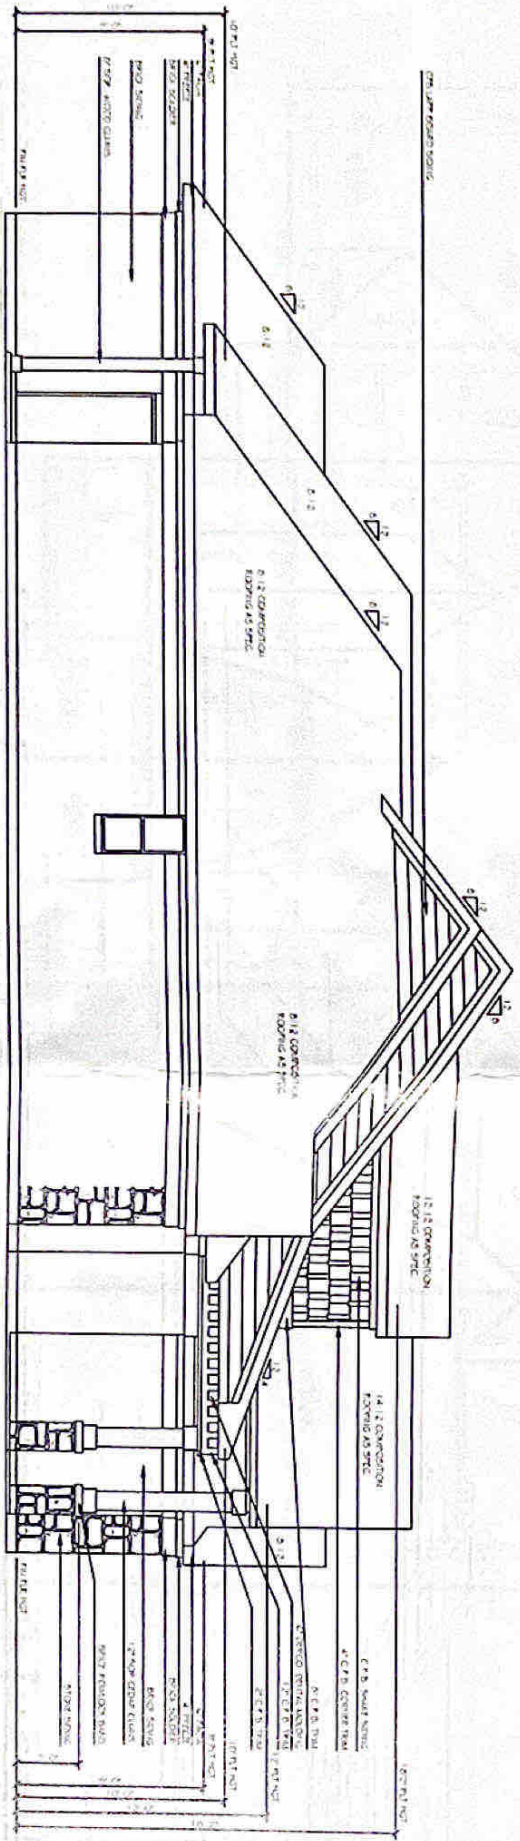

LEFT SIDE ELEVATION

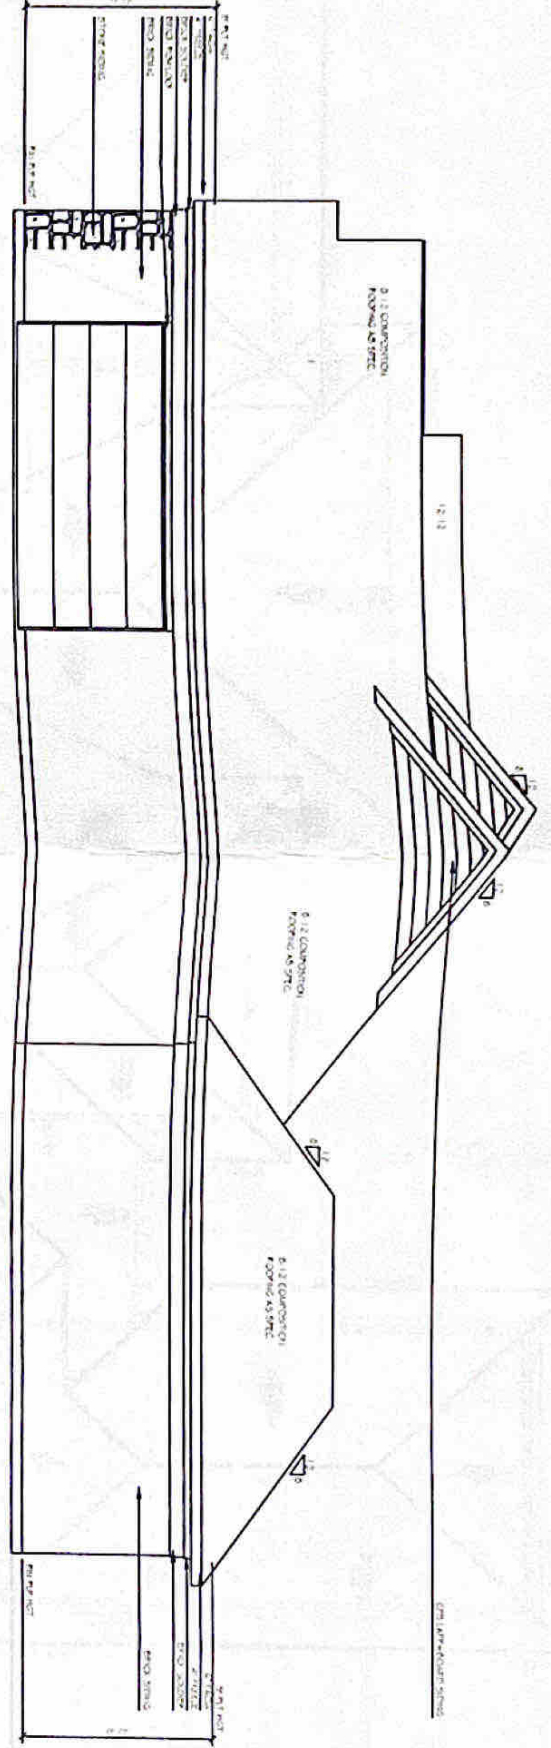

RIGHT SIDE ELEVATION

DRAWN BY: R. FISHERS CHECKED AND APPROVED: J. FISHERS DATE: 11-15-10	PROJECT: 214-215-1013	REVISION DATE: 04-05-2012	PROJECT: 214-215-1013	Crown Ridge Builders Houston, TEXAS 281-682-5593 www.crownridgebuilders.com	Homestead Designs Plano, TEXAS 214-215-1013 e-mail: homestead.designs@verizon.net	ALL COPY RIGHTS ARE THE SOLE PROPERTY OF HOMESTEAD DESIGNS

