

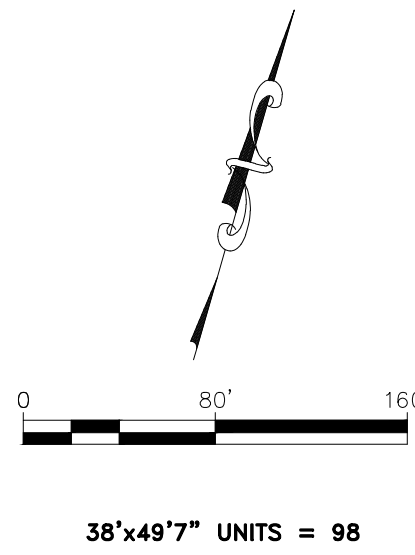


L:\SHARED\L2 ENGINEERING PROJECTS\ENGINEERING PROJECTS\10907 - MORNINGSTAR PLACE LOOP 336 DUPLEX\03 CAD\DESIGN SET\XBASE-10907-TOO.DWG Sep. 9, 2025-8:00 AM BRIAN STROKA

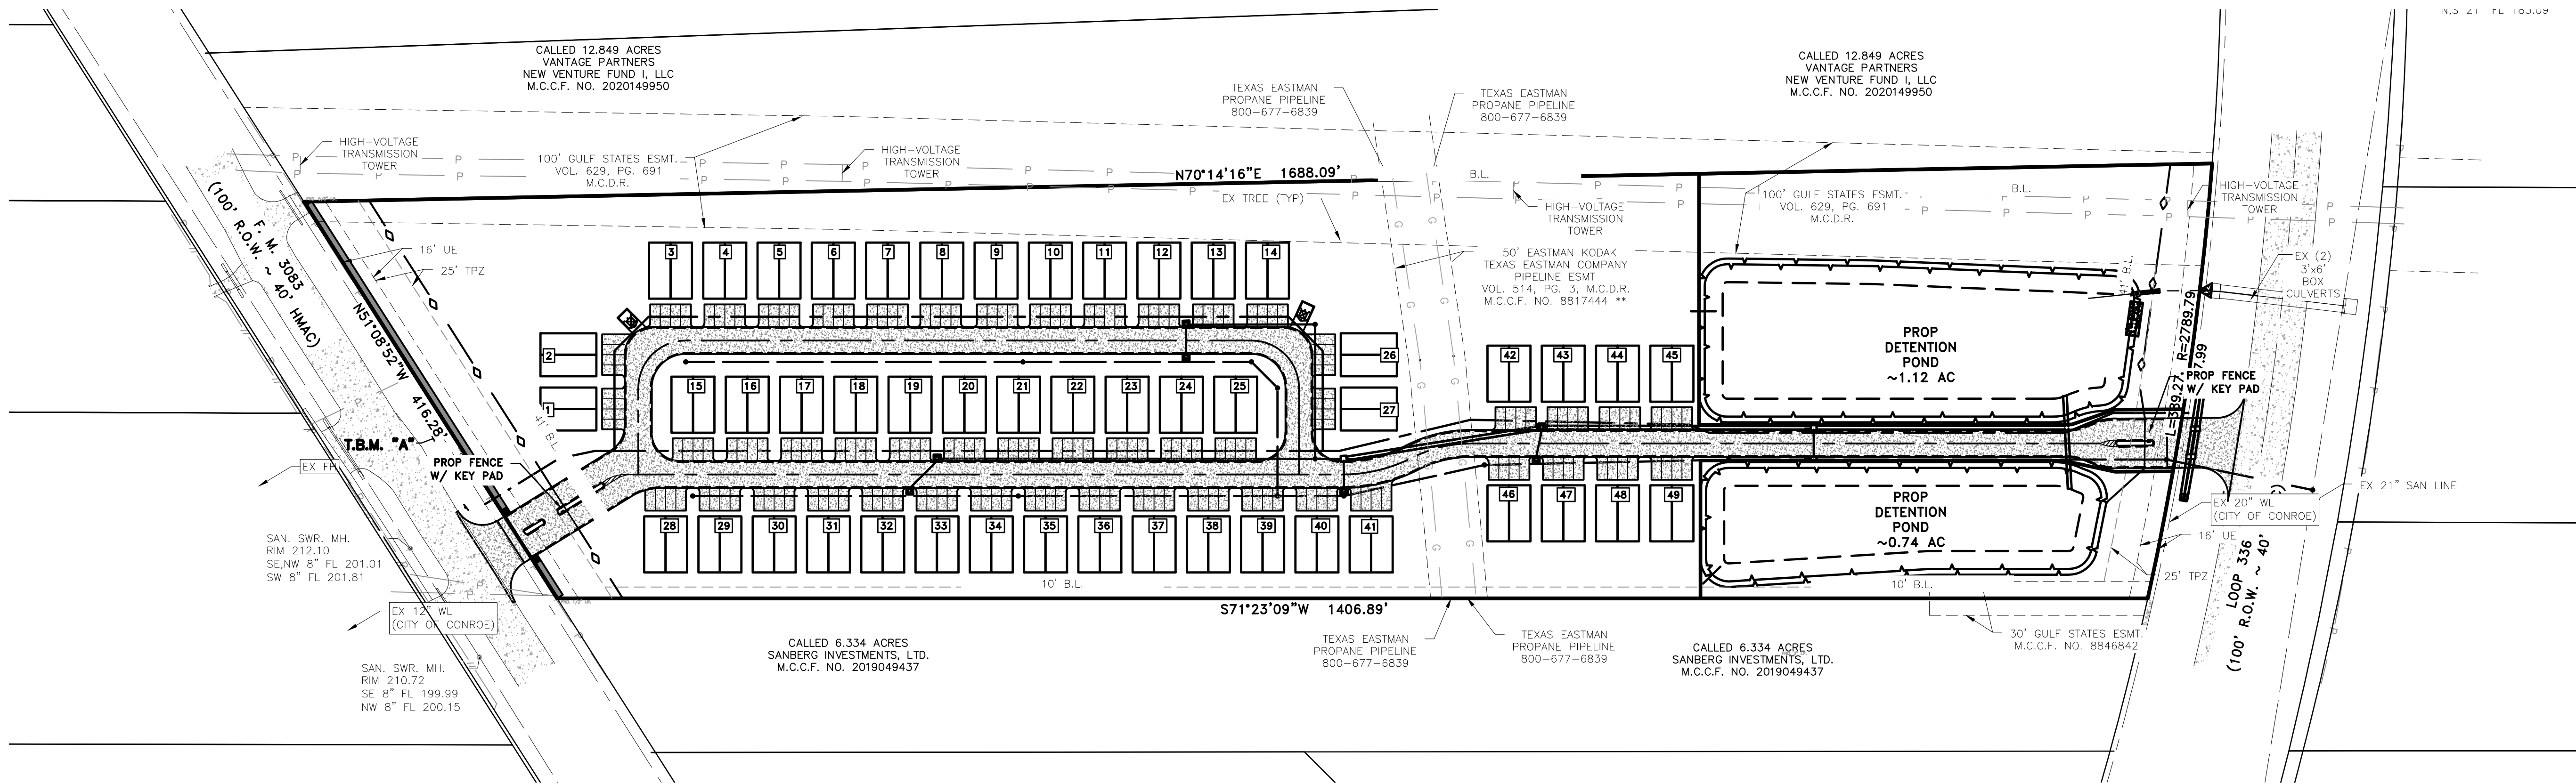

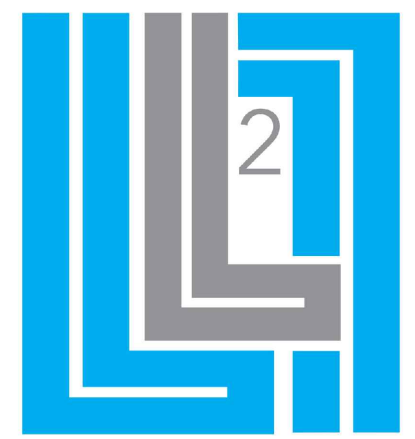

L SQUARED ENGINEERING
MUNICIPAL COMMERCIAL RESIDENTIAL
WWW.LZENGINERING.COM
NEW REGISTRATION NUMBER 13225
3307 W. DAVIS STREET #100
CONROE, TEXAS 77384
OFFICE 936-661-0430

CLIENT INFORMATION

PROJECT ADDRESS

MORNINGSTAR DUPLEX

OVERALL SITE PLAN

DRAWING ISSUE			
#	DATE	BY	* COMMENT
0	6/24/22	XXX	FOR REVIEW ONLY

DRAWING INFORMATION			
PROJECT	10907	TDLR	**
DRAWN	BAS	EIT	JTW
SCALE	SHEET		
1" = 80' (24x36)	1		
1" = 160' (11x17)			

THIS DOCUMENT IS RELEASED FOR THE PURPOSE OF INTERIM REVIEW UNDER THE AUTHORITY OF:

E. LEVI LOVE, PE #99340
OR
JONATHAN WHITE, PE #127058

FOR REVIEW PURPOSES ONLY
NOT FOR CONSTRUCTION

*PLANS NOT RELEASED FOR CONSTRUCTION UNLESS INDICATED ABOVE