



CROSS RESIDENCE WHITE OAK DRIVE LOT 39, BLOCK 1, SECTION 1 BRIDGEPOINT MONTGOMERY COUNTY, TEXAS

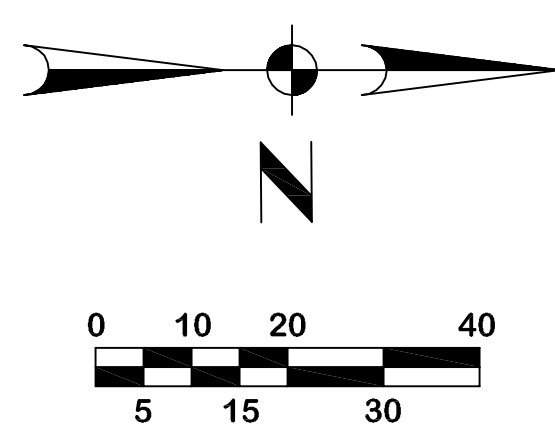

- DRAWING INDEX:**
- P1 - COVER/SITE PLAN
 - A1 - LOWER LEVEL FLOOR PLAN
 - A2 - UPPER LEVEL FLOOR PLAN
 - A3 - SHOP FLOOR PLAN, ROOF AND ELEVATIONS
 - A4 - FRONT/RIGHT ELEVATIONS
 - A5 - REAR/LEFT ELEVATIONS
 - A6 - ROOF PLAN
 - A7 - INTERIOR ELEVATIONS
 - E1 - LOWER LEVEL ELECTRICAL PLAN
 - E2 - UPPER LEVEL ELECTRICAL PLAN
 - STD-1 LEGEND SHEET
 - STD-2 NOTES & DETAILS
 - STD-3 WALL SECTIONS

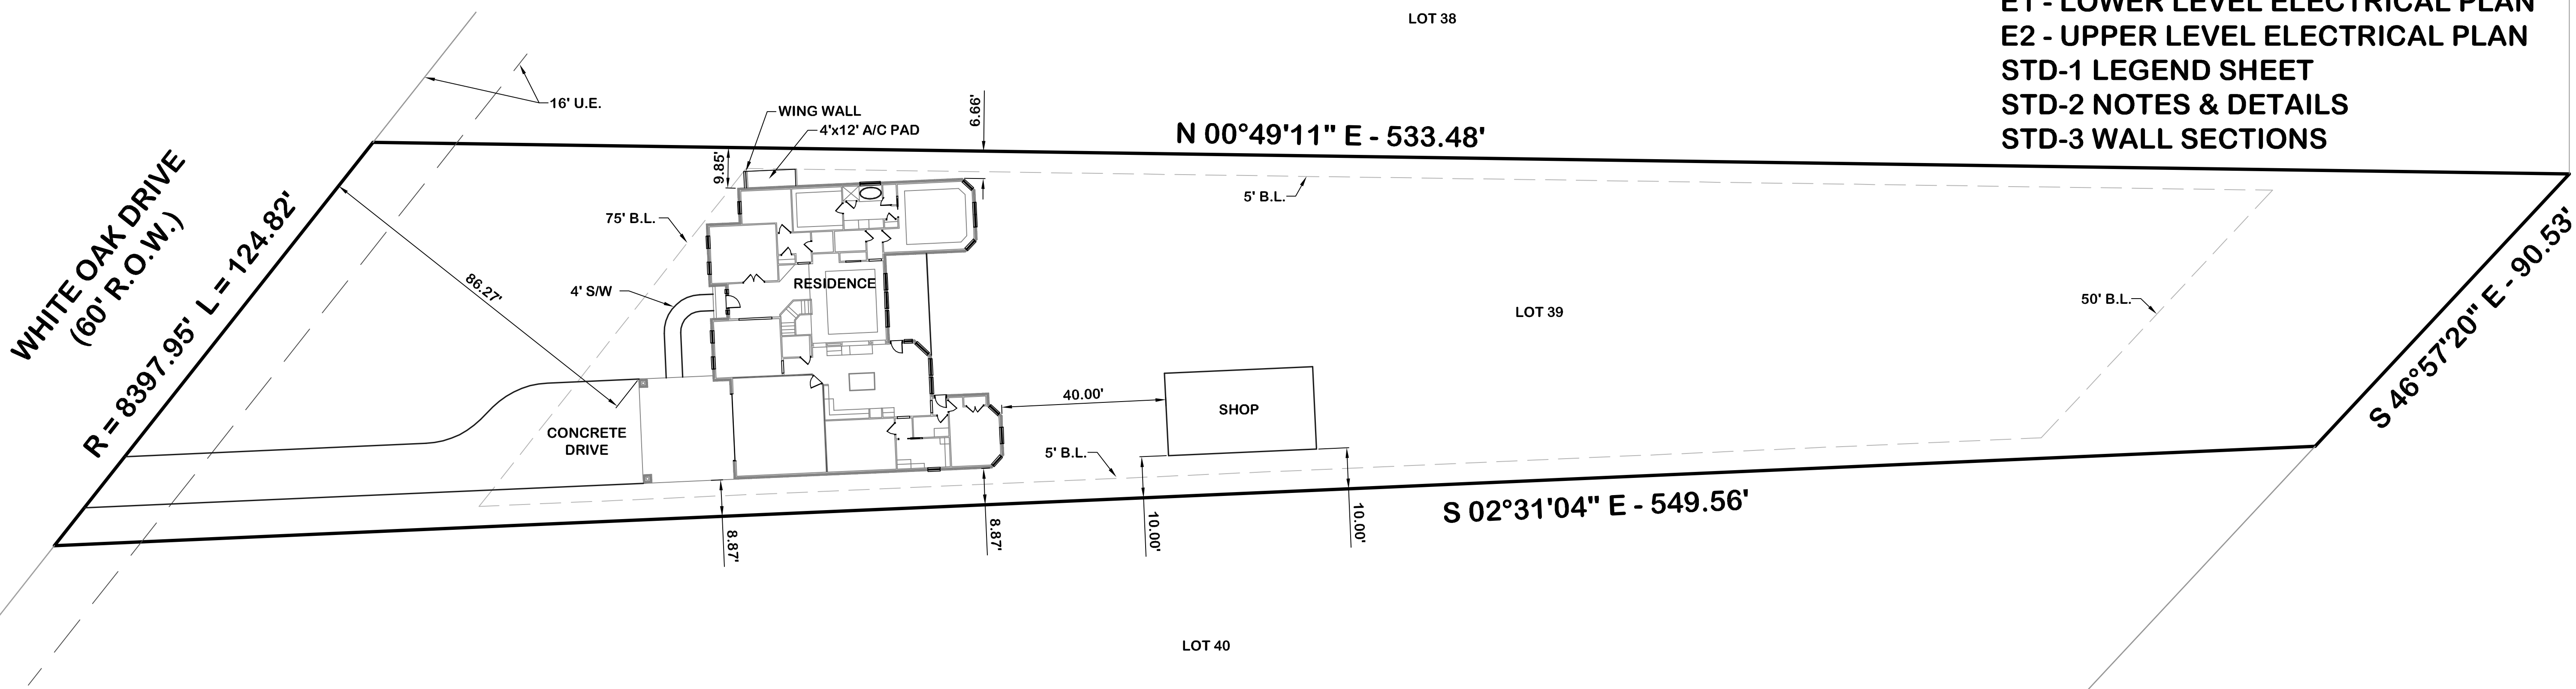

SITE PLAN
SCALE: 1"=20'-0"